
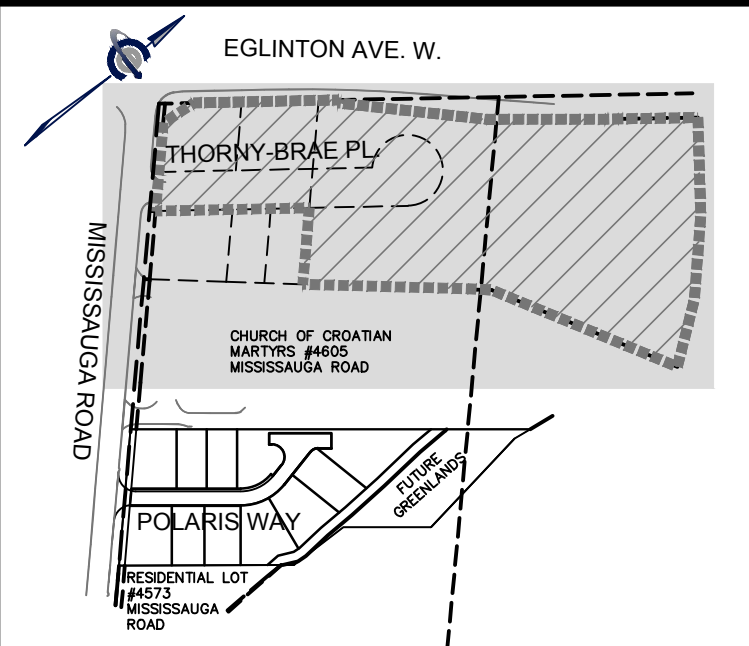


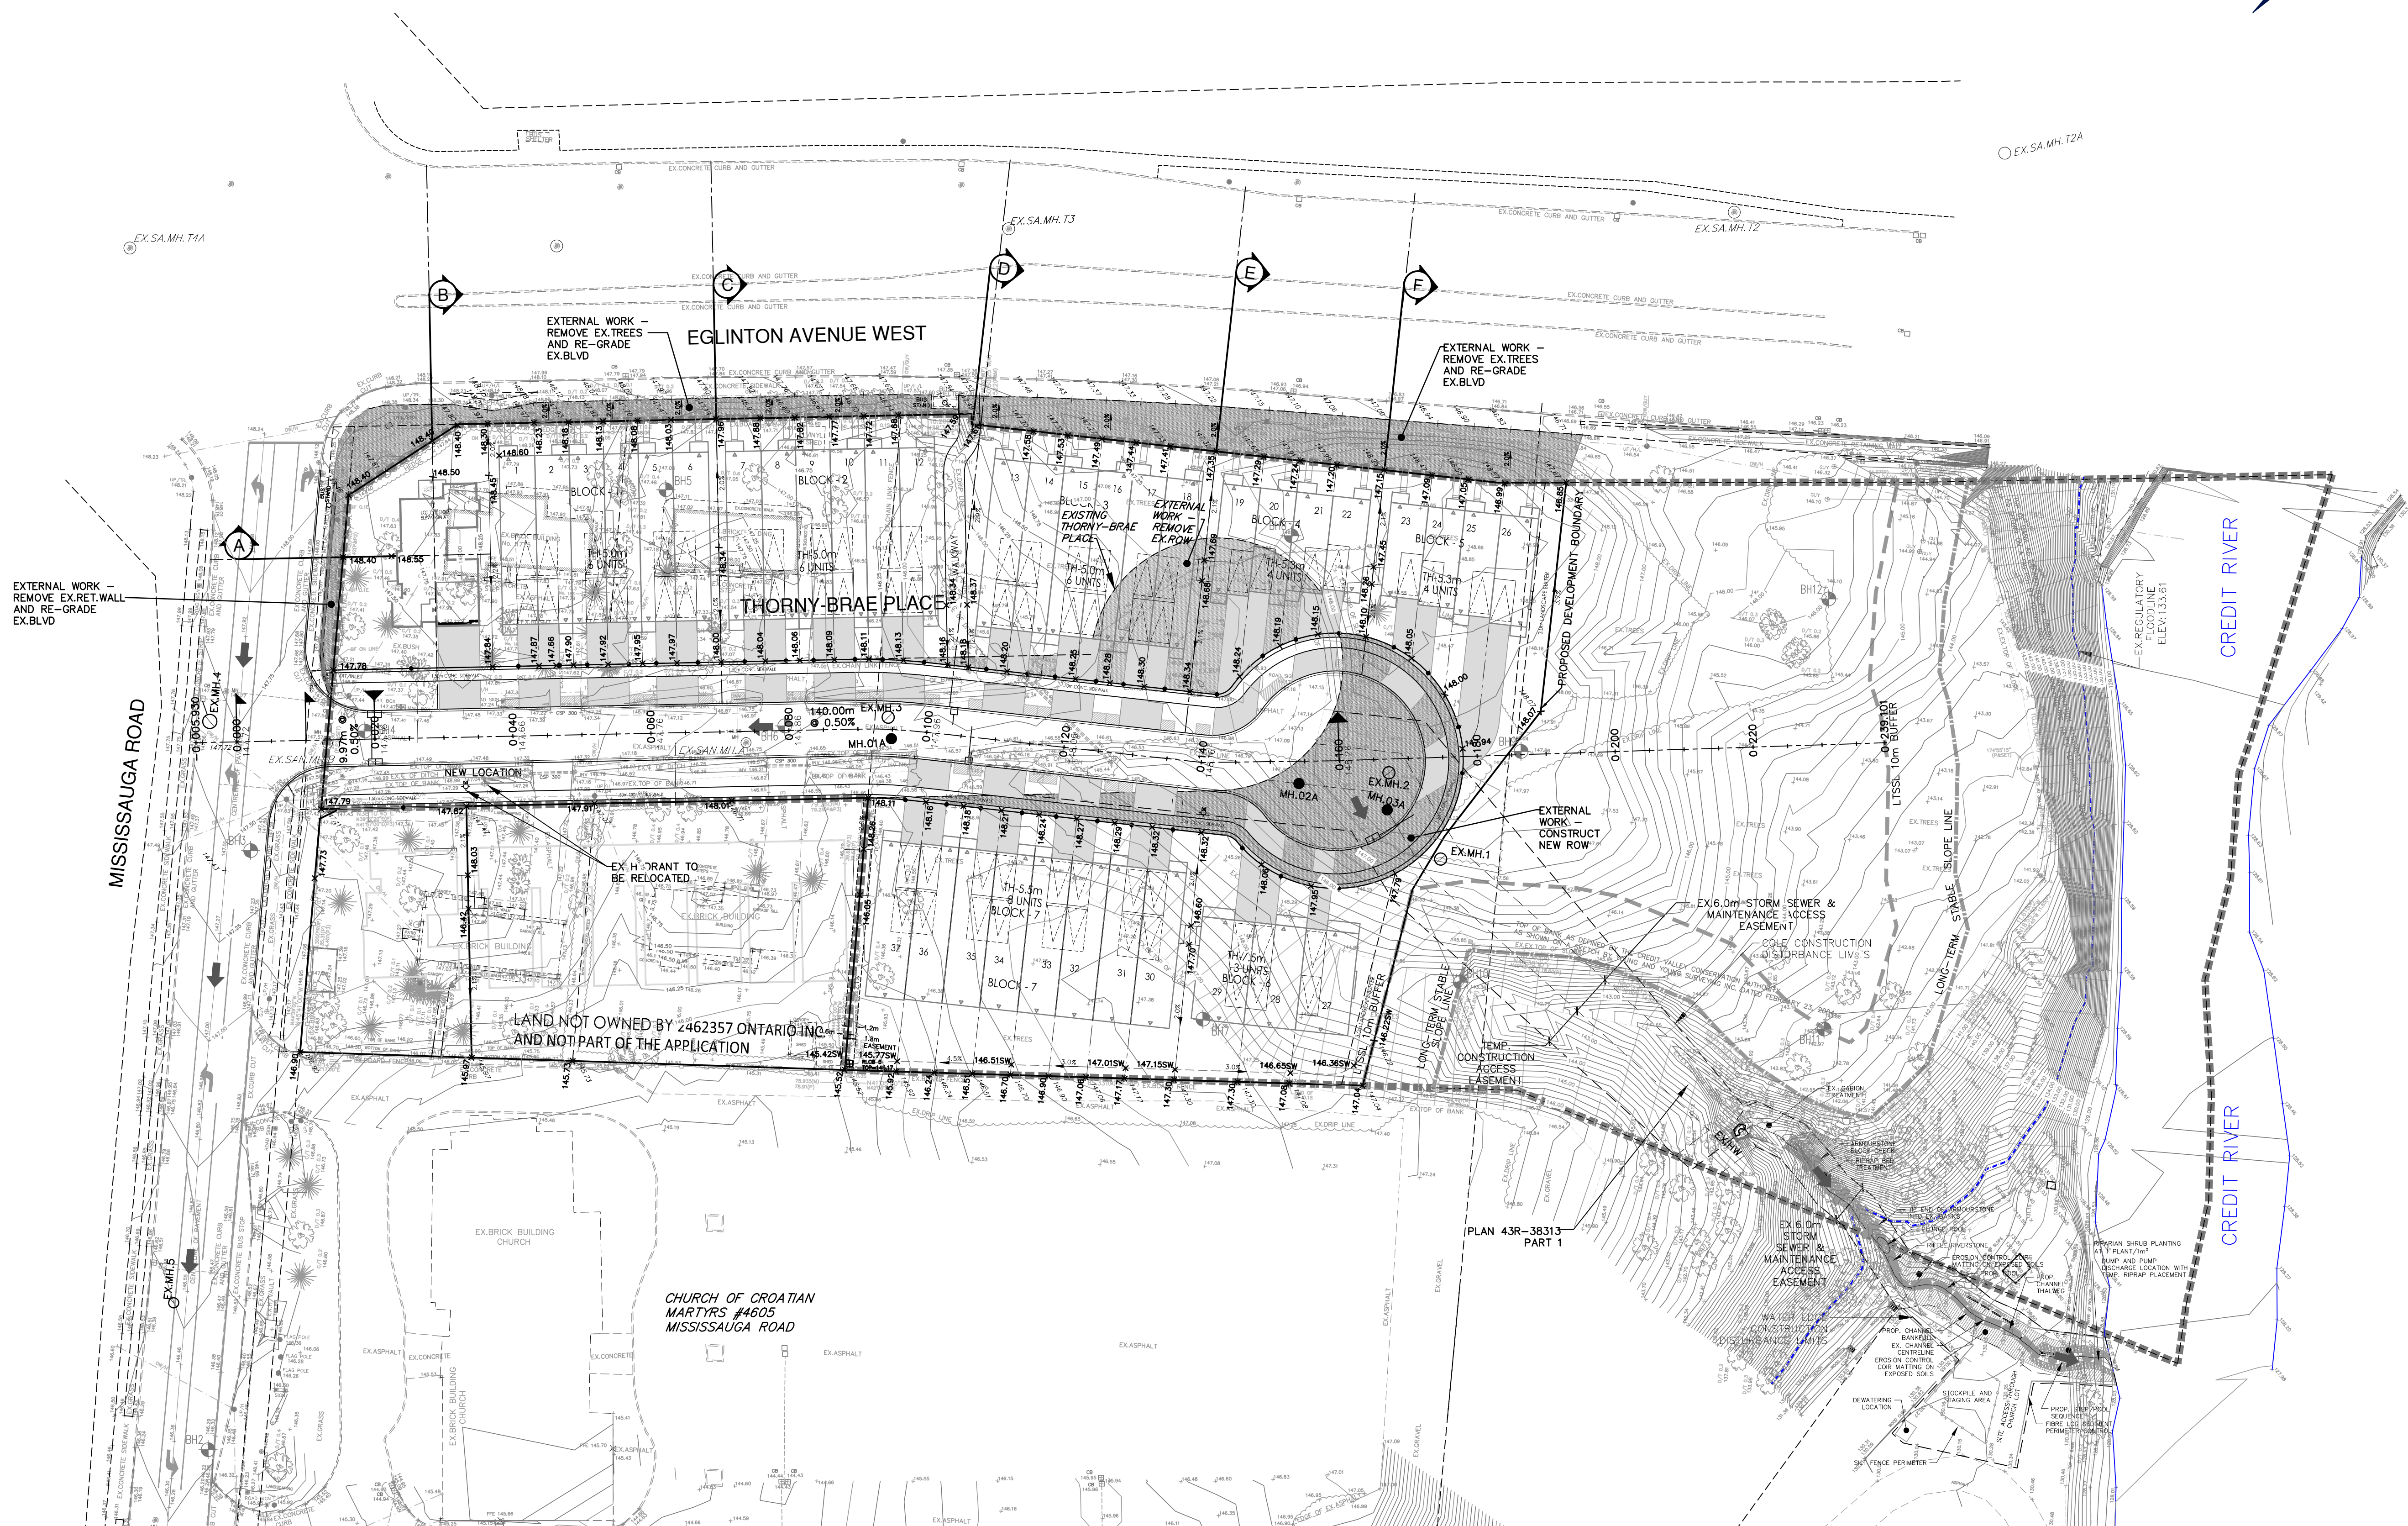

KEY PLAN
N.T.S.

LEGEND

- | | |
|---|-----------------------------------|
|  | PROPOSED STORM MANHOLE |
|  | PROPOSED STORM MANHOLE(BY OTHERS) |
|  | PROPOSED SANITARY MANHOLE |
|  | PROPOSED CATCH BASIN |
|  | PROPOSED DOUBLE CATCH BASIN |
|  | PROPOSED VALVE & BOX |
|  | PROPOSED HYDRANT & VALVE |
|  | EXISTING STORM MANHOLE |
|  | EXISTING SANITARY MANHOLE |
|  | EXISTING CATCHBASIN |
|  | EXISTING VALVE & CHAMBER |
|  | EXISTING HYDRANT & VALVE |
| 4 | PROPOSED LOT NUMBERS |
|  | PROPOSED ACOUSTIC BARRIER |
|  | PROPERTY LINE |
|  | DRIVEWAY WITH PERMEABLE PAVERS |
|  | EXISTING HYDRANT |
|  | PROPOSED HYDRANT AND VALVE |
|  | PROPOSED OVERFLOW DIRECTION |

THE DEVELOPER TO VERIFY INVERT ELEVATION AND LOCATION OF ALL UNDERGROUND SERVICES AND UTILITIES PRIOR TO COMMENCING WORK.

EXISTING SERVICING INFORMATION FOR MISSISSAUGA ROAD AND THORNY-BRAE PLACE WAS OBTAINED FROM MUNICIPAL RECORD DRAWINGS: C-33221, C-33222, C-99829, 1156-D, 7235-D
EXISTING SERVICING AND UTILITIES INFORMATION SHOWN ON THIS DRAWING IS NOT TO BE RELIED ON. THE CONTRACTOR TO VERIFY INVERT ELEVATION AND LOCATION OF ALL UNDERGROUND SERVICES AND UTILITIES PRIOR TO COMMENCING WORK.

SITE PLAN INFORMATION

SCHAEFFER DZALDOV BENNETT LTD.
64 JARDIN DRIVE
CONCORD, ONTARIO L4K 3P3
PHONE: (416) 987-0101
FAX: (905) 761 - 0101

SURVEY INFORMATION

SCHAEFFER DZALDOV BENNETT LTD.
64 JARDIN DRIVE
CONCORD, ONTARIO L4K 3P3
PHONE: (416) 987-0101
FAX: (905) 761 - 0101

BENCHMARK

ELEVATIONS SHOWN HEREON ARE REFERRED TO
CITY OF MISSISSAUGA BENCHMARK No. 970,
HAVING A PUBLISHED ELEVATION OF 148.702 METRES

3.	3RD SUBMISSION	MAR 7, 2019	S.G.
2.	2ND SUBMISSION	JUNE 6, 2018	S.G.
1.	PRE-SUBMISSION REVIEW	NOV 22, 2017	S.G.
NO.	REVISION	DATE	BY

NO.	REVISION		DATE		BY
FIRST		SECOND		INTERIM	FINAL
	DATE		DATE		DATE

[illegible]

MISSISSAUGA, ON

FUNCTIONAL GRADING PLAN



DESIGNED BY: P.F.	DATE: NOVEMBER 2017	CHECKED BY: S.G.
-------------------	---------------------	------------------

DRAWN BY: A.A.	PROJECT No.	APPROVED BY: S.G.
----------------	-------------	-------------------

SCALE: 1:500	UD15-0682	DRAWING No.
--------------	-----------	-------------

UD 15-0682 SG-01

Core Engineering Group Ltd.		
-----------------------------	--	--