


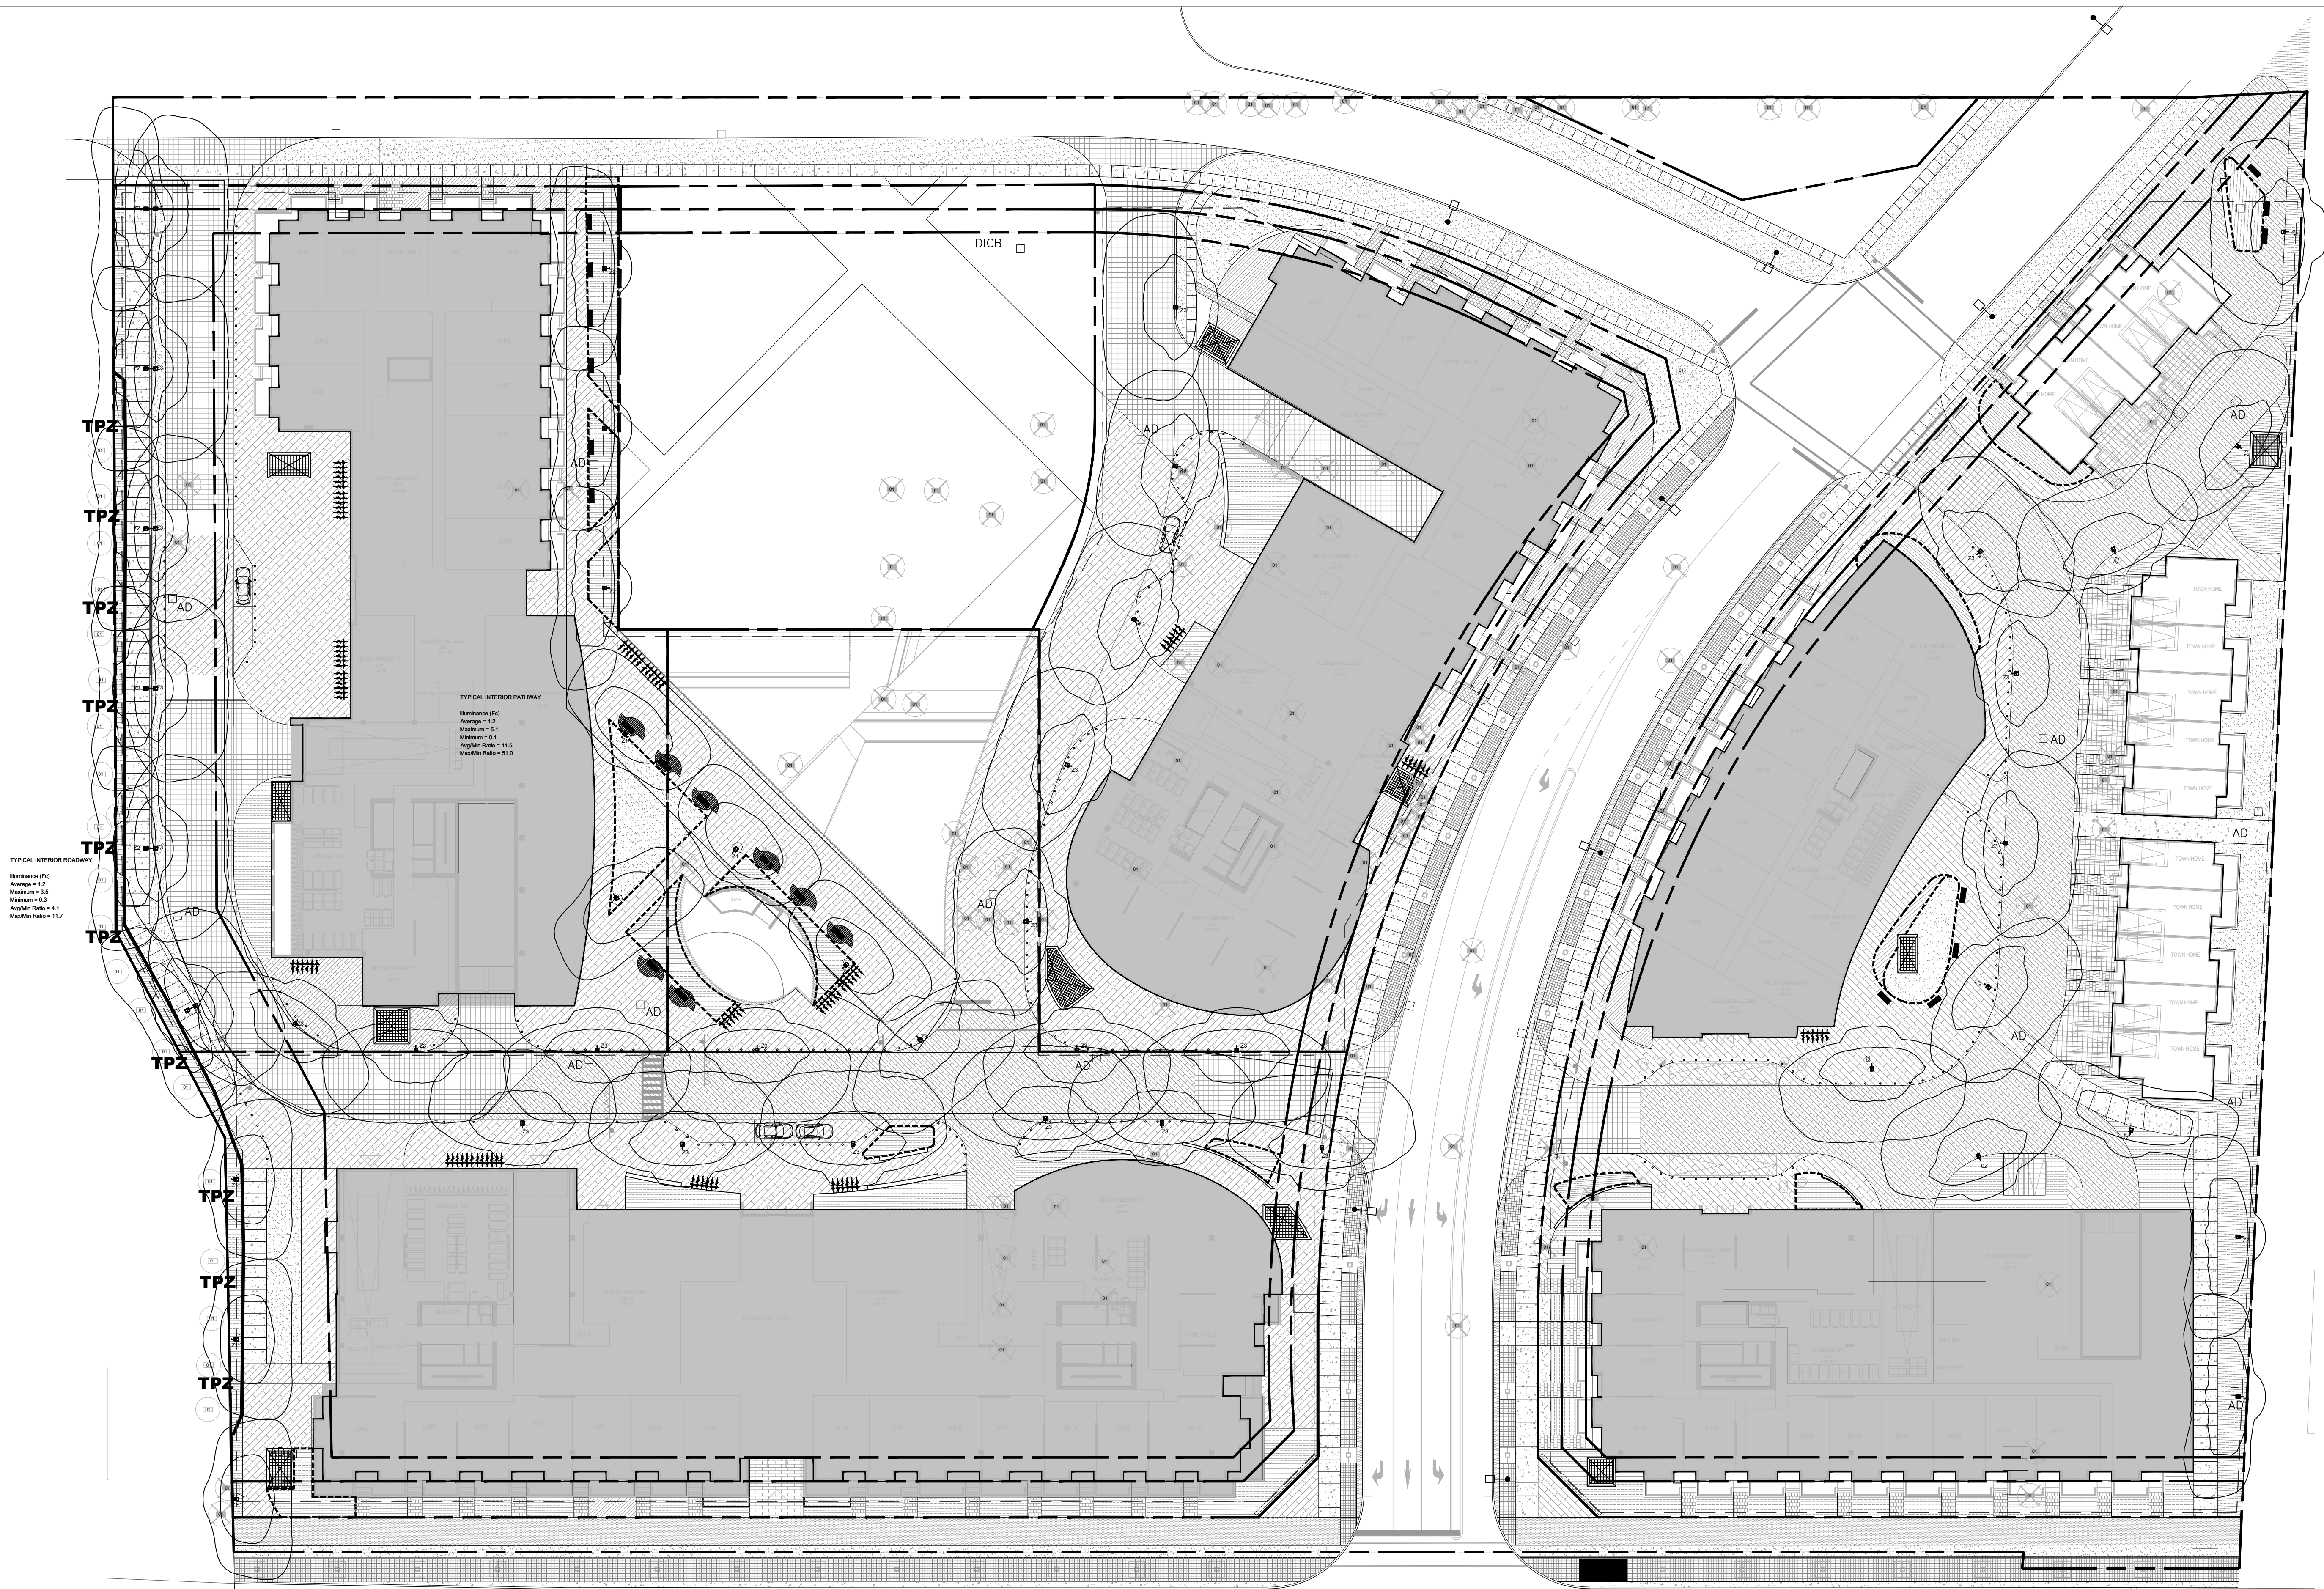



SALEX PROJECT: A18103 - 91 EGLINTON EXTERIOR SITE LIGHTING

Luminaire Schedule						
Symbol	Label	Description	Manufacturer	Lum. Lumens	LLD	Qty
	Z1	VFL530 LED 661-5321 4000K Type III Short	WE-EF USA	2646	0.900	26
	Z2	VFL530 LED 661-5321 4000K Type II Short	WE-EF USA	2621	0.900	26
	Z3	VFL530 LED 661-5325 4000K Type IV Medium	WE-EF USA	2902	0.900	27

NOTES:
1. Calculation grid spacing 3.0m X 3.0m at Ground Level.
2. All pole mounted fixtures modelled with fixture heads at 3.6m (12-FT) above grade.

Calculation Summary							
Label	CalcType	Units	Avg	Max	Min	Avg/Min	Max/Min
TYPICAL INTERIOR PATHWAY	Illuminance	Fc	1.2	5.1	0.1	11.6	51.0
TYPICAL INTERIOR ROADWAY	Illuminance	Fc	1.2	3.5	0.3	4.1	11.7

  1:400



CLIENT

91 EGLINTON AVE E

MISSISSAUGA, ONTARIO

PROJECT

PHOTOMETRIC PLAN

DRAWING

DRAWN: RR

CHECKED: JC

SCALE: AS SHOWN

DATE: 2018-08-31

PROJECT NO.: 18-132

SHEET NO.:

LS-101

3	ISSUED FOR REZONE 2	2019-05-31	RR
2	131 EGLINTON AVE. E LANDS ADDED	2019-01-18	RR
1	ISSUED FOR REZONE	2018-09-20	RR
no.	revision	date	by

CONTRACTOR MUST VERIFY ALL DIMENSIONS ON THE JOB AND REPORT ANY DISCREPANCY TO THE LANDSCAPE ARCHITECT BEFORE PROCEEDING WITH THE WORK.
ALL DRAWINGS AND SPECIFICATIONS ARE INSTRUMENTS OF SERVICE AND THE PROPERTY OF THE LANDSCAPE ARCHITECT WHICH MUST BE RETURNED AT THE COMPLETION OF THE WORK.
ALL DRAWINGS TO BE USED FOR CONSTRUCTION ONLY WHEN SIGNED BY THE LANDSCAPE ARCHITECT.

signed _____ date _____

terraplan
LANDSCAPE ARCHITECTS
VISION. DELIVERED.

20 Champlain Blvd. Suite 102 - Toronto ON - M3H 2Z1 info@terraplan.ca www.terraplan.ca

