


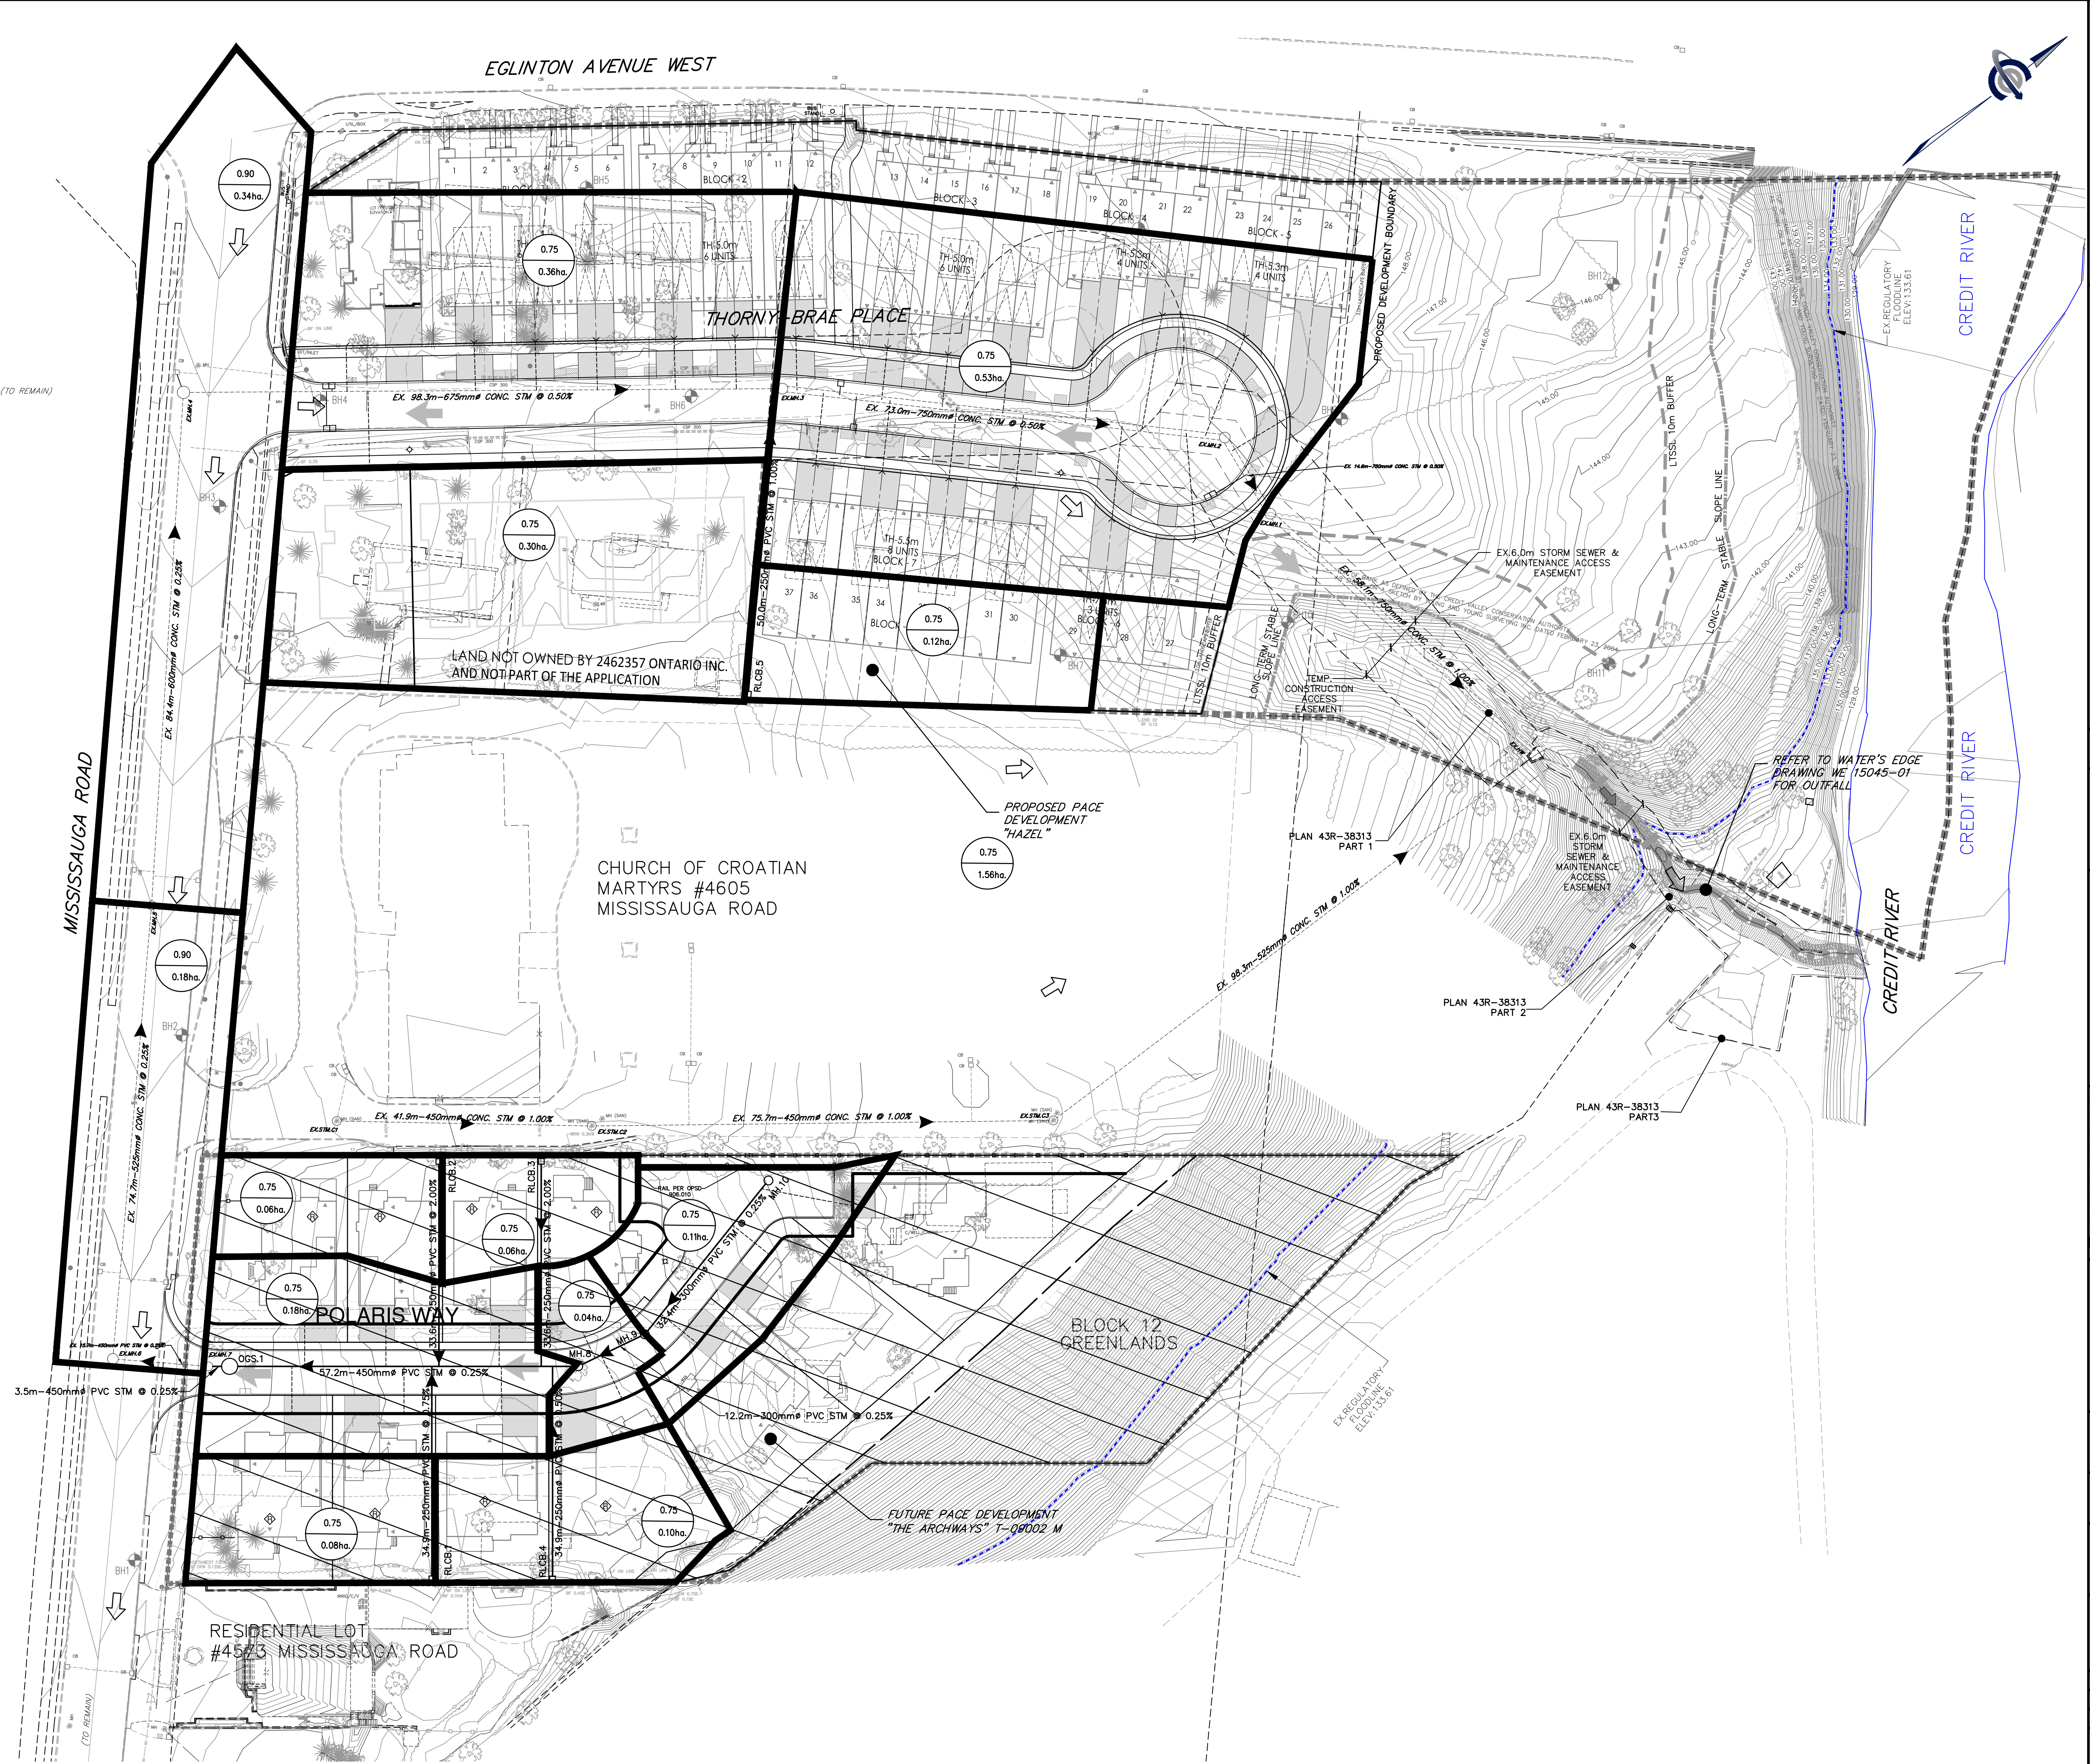

EGLINTON AVE. W.

THORNY-BRAE PL

CHURCH OF CROATIAN MARTYRS #4605

MISSISSAUGA ROAD

POLARIS WAY

MISSISSAUGA ROAD

MISSISSAUGA ROAD

KEY PLAN
N.T.S.

LEGEND

- PROPOSED STORM MANHOLE
- PROPOSED SANITARY MANHOLE
- PROPOSED CATCH BASIN
- PROPOSED DOUBLE CATCH BASIN
- PROPOSED VALVE & BOX
- PROPOSED HYDRANT & VALVE
- EXISTING STORM MANHOLE
- EXISTING SANITARY MANHOLE
- EXISTING CATCHBASIN
- EXISTING VALVE & CHAMBER
- EXISTING HYDRANT & VALVE
- PROPOSED LOT NUMBERS
- PROPOSED 2.0m HIGH ACOUSTIC FENCE
- PROPOSED 2.0m HIGH LIGHT DUTY ACOUSTIC FENCE
- PROPERTY LINE (2462357 ONTARIO INC.)
- DRAINAGE AREA BOUNDARY
- 0.45 RUNOFF COEFFICIENT
- 0.06ha AREA
- EXISTING OVERLAND FLOW
- PROPOSED OVERLAND FLOW
- FUTURE OVERLAND FLOW

135

PROPOSED 2.0m HIGH ACOUSTIC FENCE

PROPOSED 2.0m HIGH LIGHT DUTY ACOUSTIC FENCE

PROPERTY LINE (2462357 ONTARIO INC.)

DRAINAGE AREA BOUNDARY

0.45 RUNOFF COEFFICIENT

0.06ha AREA

EXISTING OVERLAND FLOW

PROPOSED OVERLAND FLOW

FUTURE OVERLAND FLOW

THE DEVELOPER TO VERIFY INVERT ELEVATION AND LOCATION OF ALL UNDERGROUND SERVICES AND UTILITIES PRIOR TO COMMENCING WORK.

EXISTING SERVICING INFORMATION FOR MISSISSAUGA ROAD AND THORNY-BRAE PLACE WAS OBTAINED FROM MUNICIPAL RECORD DRAWINGS: C-33221, C-33222, C-39929, T-159-D, T-235-D. EXISTING SERVICING AND UTILITIES INFORMATION SHOWN ON THIS DRAWING IS NOT TO BE RELIED ON. THE CONTRACTOR TO VERIFY INVERT ELEVATION AND LOCATION OF ALL UNDERGROUND SERVICES AND UTILITIES PRIOR TO COMMENCING WORK.

SITE PLAN INFORMATION

SCHAEFFER DZALDOV BENNETT LTD.
64 JARDIN DRIVE
CONCORD, ONTARIO L4K 3P3
PHONE: (416) 887-0101
FAX: (905) 761-0101

SURVEY INFORMATION

SCHAEFFER DZALDOV BENNETT LTD.
64 JARDIN DRIVE
CONCORD, ONTARIO L4K 3P3
PHONE: (416) 887-0101
FAX: (905) 761-0101

BENCHMARK

ELEVATIONS SHOWN HEREON ARE REFERRED TO CITY OF MISSISSAUGA BENCHMARK No. 970, HAVING A PUBLISHED ELEVATION OF 148.702 METRES.

NO.	REVISION	DATE	BY
3.	3RD SUBMISSION	MAR 7, 2019	S.G.
2.	2ND SUBMISSION	JUNE 6, 2018	S.G.
1.	PRE-SUBMISSION REVIEW	NOV 22, 2017	S.G.

NO.	REVISION	DATE	BY
1.	PRE-SUBMISSION REVIEW	NOV 22, 2017	S.G.

Region of Peel
working with you

MISSISSAUGA

THE HAZEL
MISSISSAUGA, ON

STORM DRAINAGE PLAN

COLE ENGINEERING

DESIGNED BY: P.F. DATE: OCTOBER 2015 CHECKED BY: S.G.

DRAWN BY: P.F. PROJECT No. APPROVED BY: S.G.

SCALE: 1:500 UD15-0682 DRAWING No. ST-01

© COPYRIGHT 2015 Cole Engineering Group Ltd.